


implementable signaling devices		
position	device	symbol
A	push button, 4 x 0.34mm <sup>2</sup>	
A	domed push button, 4 x 0.34mm <sup>2</sup>	
A	push button 2-positions, 4 x 0.34mm <sup>2</sup>	
A	key switch, 4 x 0.34mm <sup>2</sup>	
A	pull switch, 4 x 0.34mm <sup>2</sup>	
A	elbow push switch, 4 x 0.34mm <sup>2</sup>	
A	FGS wired UTP Cat5, 8 wires Ø0,5mm	
B	wall socket: 230V, 3 x 2.5mm <sup>2</sup>	
C	photocell incl. cable	
D	motion sensor incl. cable	

other implementable electrical devices	
INPUT:	- intercom
	- fire alarm system
	potential free contact switch
OUTPUT:	- bel switch
	- alarm system
	I <sub>max</sub> = 400mA

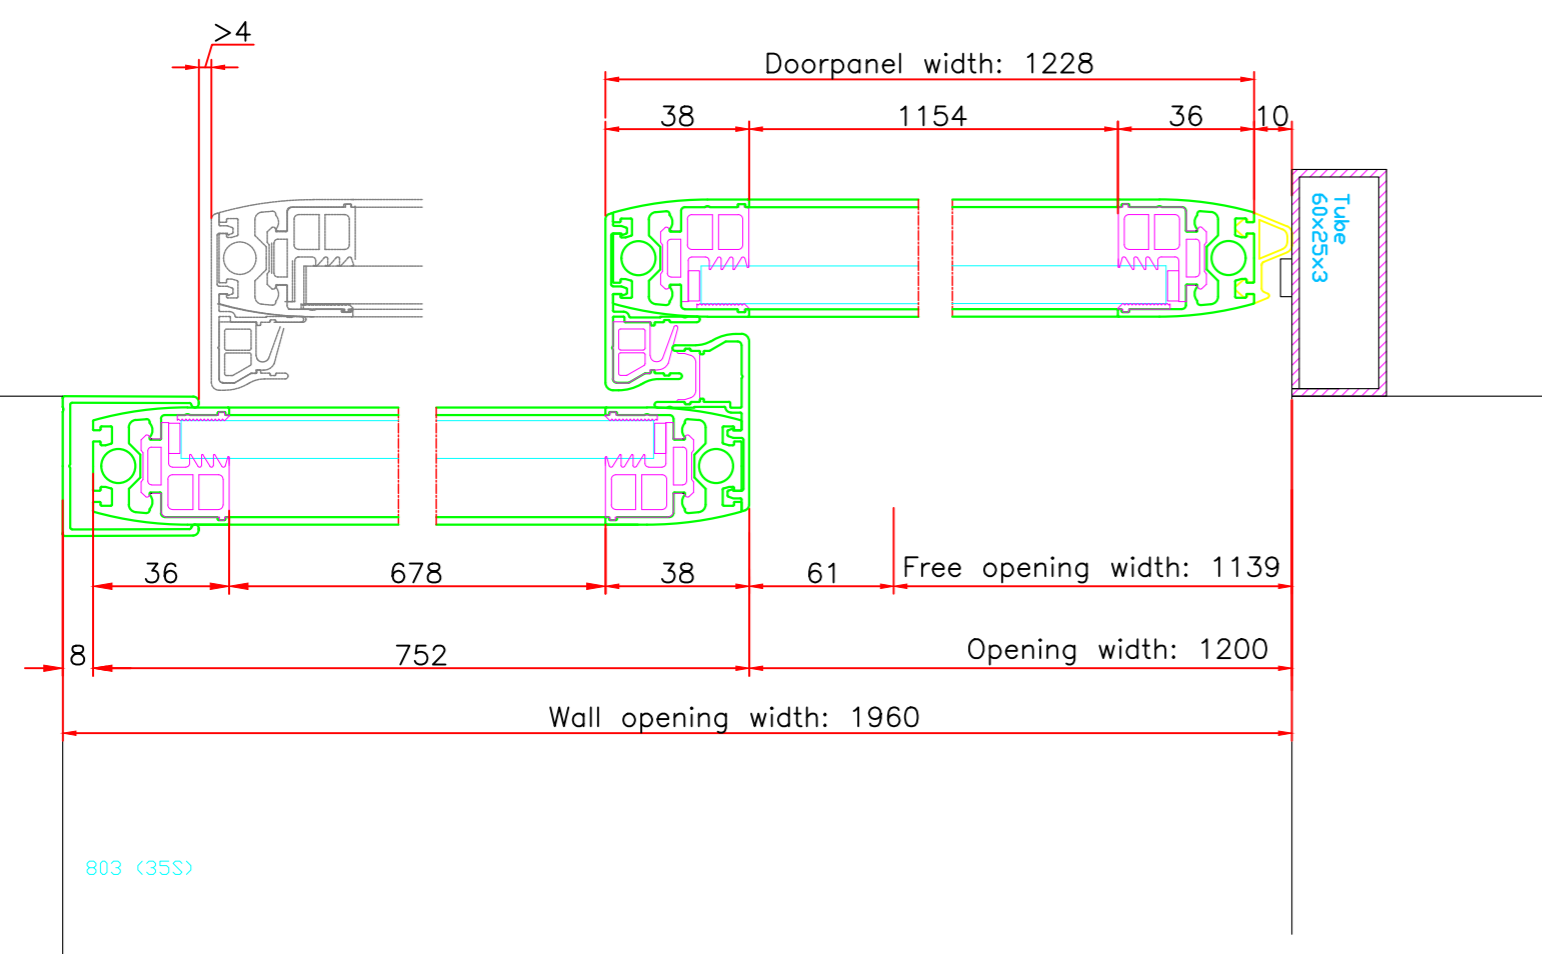

Title: KONE SD70 SD-S-FP			Drawing number:
Order number:	Page no.:	Projectie ISO-128	Revision number:
Date:	Scale:		A:
Drawn by:	Paper size:		B:
			C:
			Copyright by KONE
Smalle Zijde 20A Postbus 94 3900 AB Veenendaal Tel.: 0318 - 532333 Fax: 0318 - 532339			